

装饰施工图纸

2019.10

日期	姓名	专业
		暖通
		电气
		给排水
		建筑
		专业


序号	图号	图名	序号	图号	图名
1		封面	23		
2	目录-01	图纸目录	24		
3	P-01	原始平面图	25		
4	P-02	平面布置图	26		
5	P-03	隔墙尺寸图	27		
6	P-04	顶面布置图	28		
7	P-05	灯具尺寸图	29		
8	P-06	地面铺装图	30		
9	P-07	插座布置图	31		
10	P-08	墙面材质分析说明图	32		
11	P-09	大样图	33		
12					
13					
14					
15					
16					
17					
18					
19					
20					
21					
22					

建筑设计单位
ARCHITECTURE DESIGN UNIT

合作设计
CO-OPERATION FIRM

本图纸中以标注尺寸为准，尺寸不得测量。


专业	姓名	日期	专业	姓名	日期
建筑			暖通		
结构			电气		
给排水					

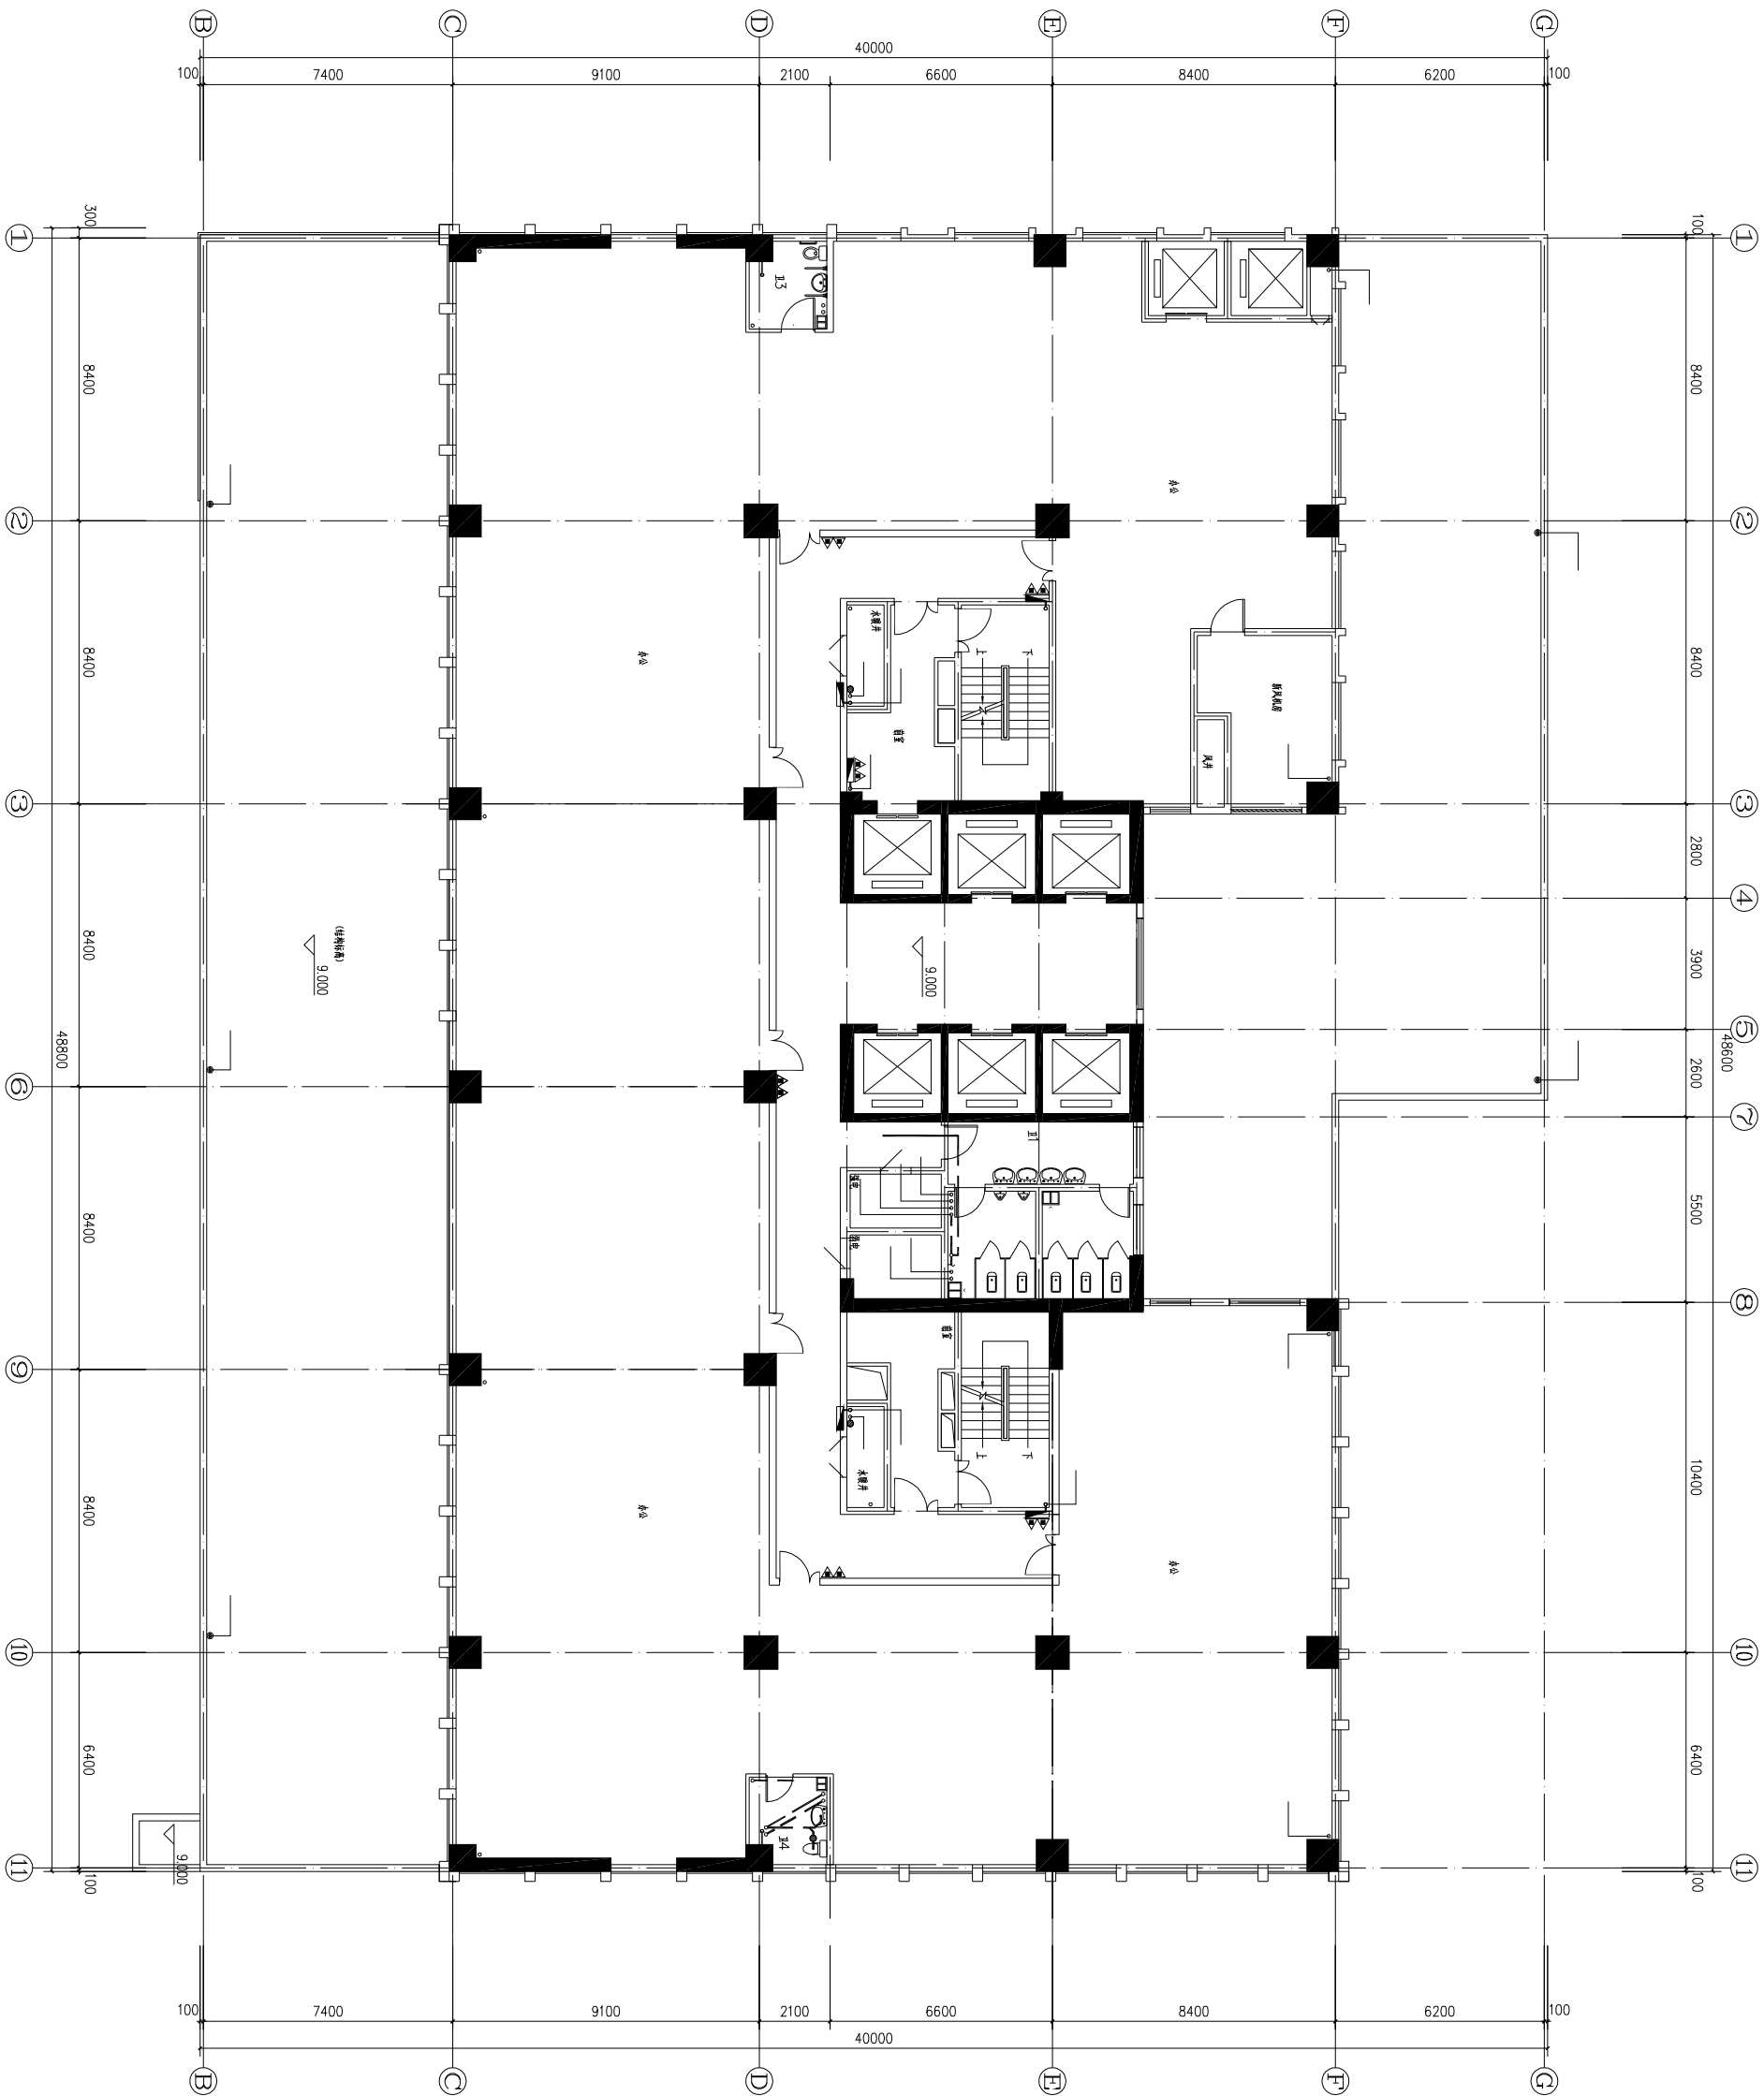

原始平面图


[illegible]

专业	姓名	日期	专业	姓名	日期
建筑			暖通		
结构			电气		
给排水					

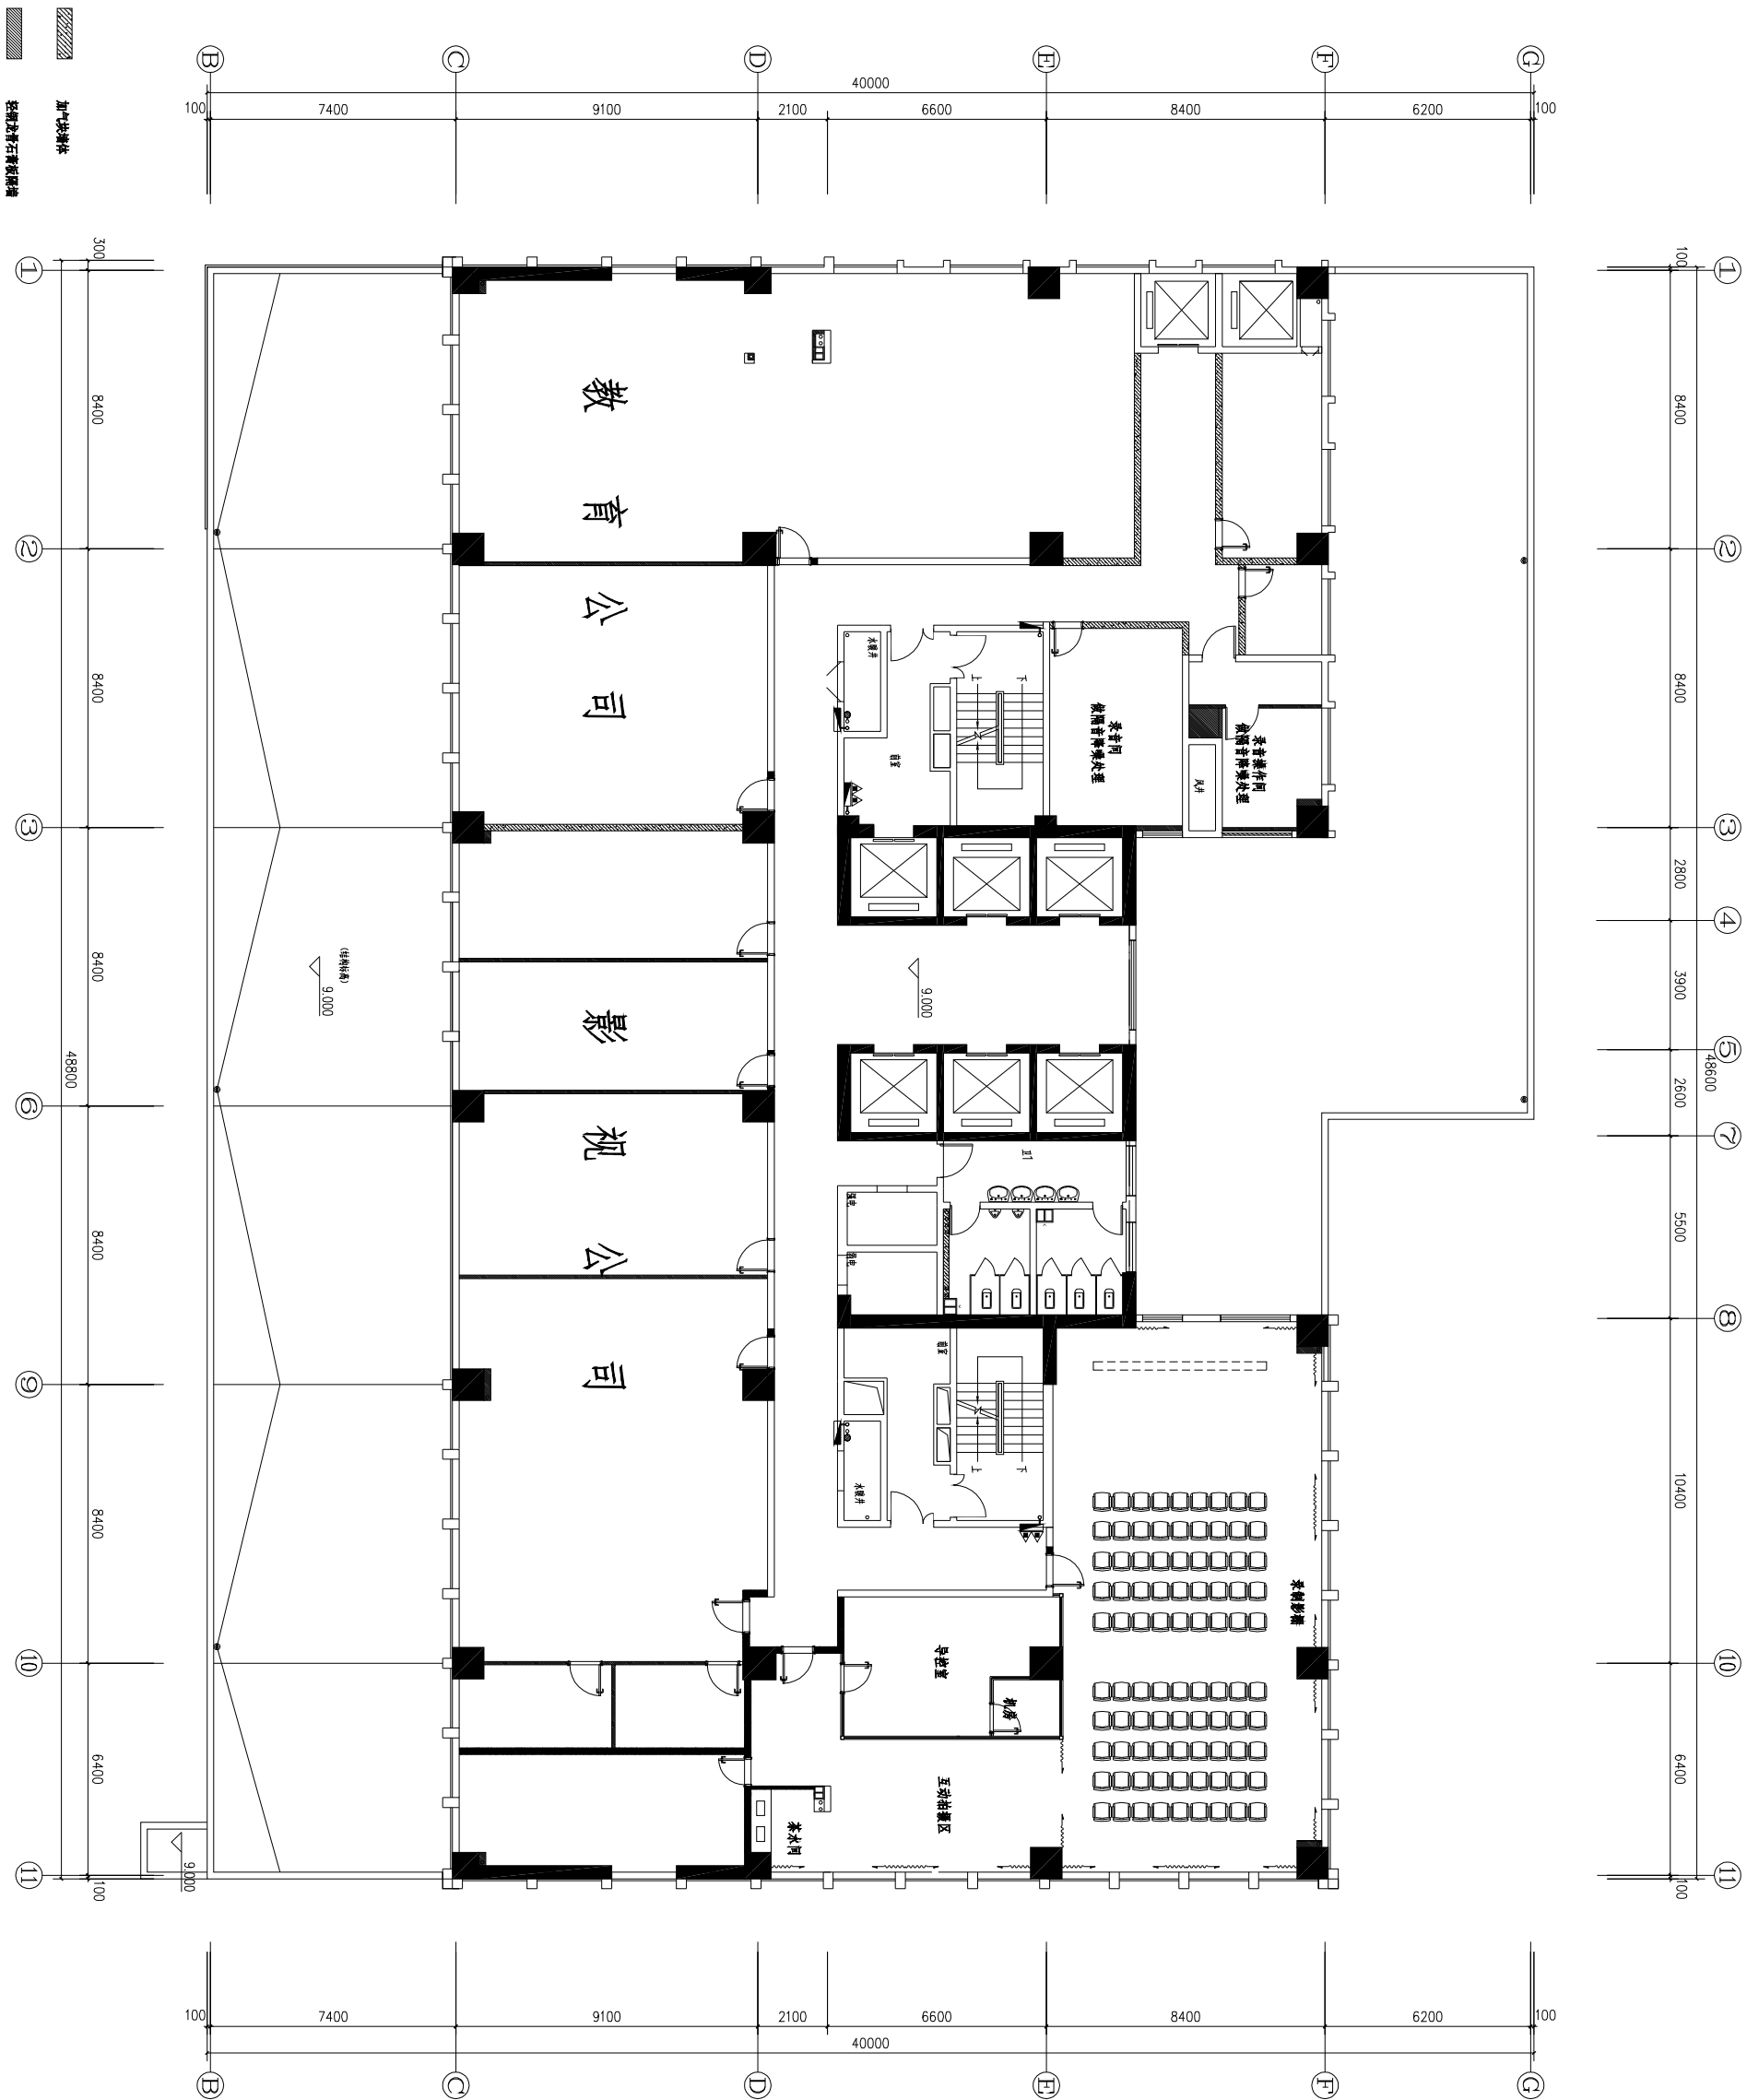

建筑设计单位 ARCHITECTURAL DESIGN UNIT					
合作设计 CO-DESIGN TITLE					
本图纸中以标注尺寸为准，尺寸不得随意。					
日期					
版本	原始版	修改版	修改版	修改版	
设计师 DRAWING PERSONNEL CHANG PROJECT TEAM					
注册建筑师 REGISTERED ARCHT. REGISTERED SEAL					
审 定					
项目负责人 PROJECT MANAGER					
专业负责人 DESIGNED BY RESPONSIBLE PT.					
校 对 CHECKED BY					
核 对 CORRECTED BY					
总 计 TOTAL SHEET					
工程名称 PROJECT NAME					
项目名称 ITEM NAME					
图 名 DRAWING TITLE 平 面 布 置 图					
工图编号 PROJECT No.	2019-10				
图 别					
图 号	P-02				
日 期	2019/10/10				

专业	姓名	日期	专业	姓名	日期
建筑			暖通		
结构			电气		
给排水					

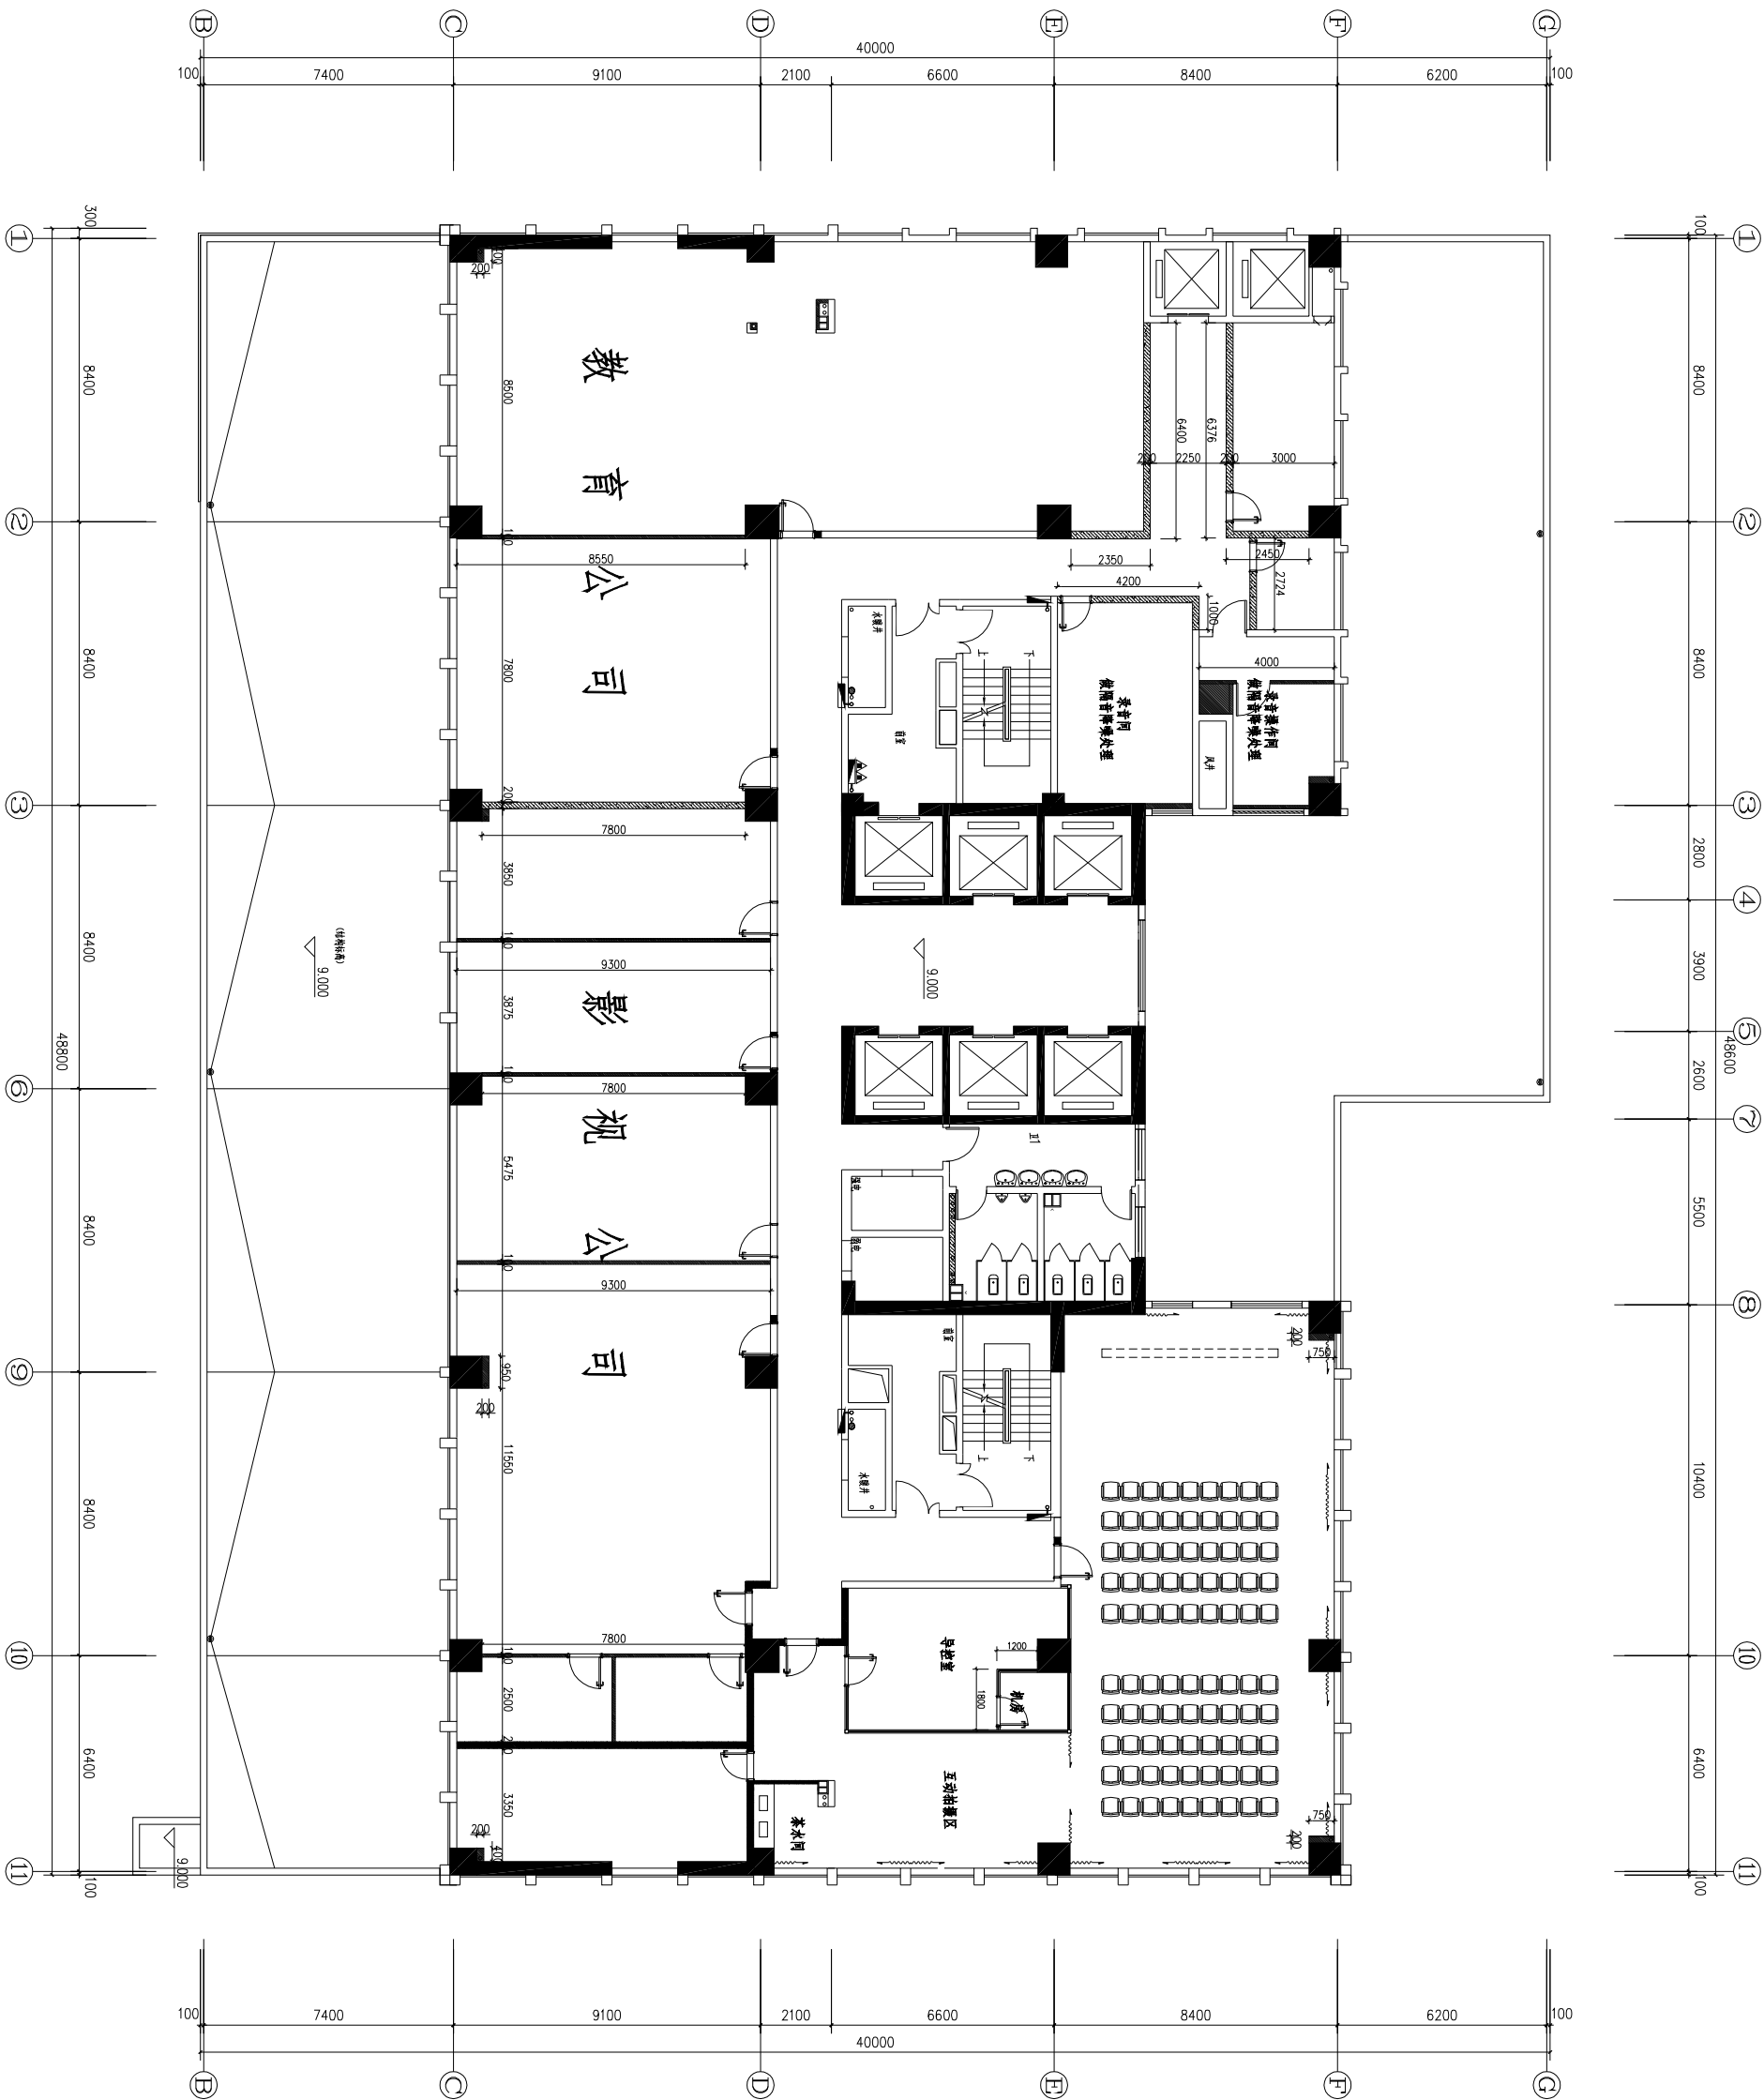

建筑设计单位 ARCHITECTURAL UNIT			
合作设计 CO-DESIGN TITLE			
本图纸中以标注尺寸为准，尺寸不得测量。			
注册建筑师 REGISTERED ARCHITECT 注册结构师 REGISTERED STRUCTURAL ENGINEER 注册设备工程师 REGISTERED ELECTRICAL ENGINEER 注册暖通工程师 REGISTERED MECHANICAL ENGINEER 注册给排水工程师 REGISTERED WATER SUPPLY ENGINEER 注册动力工程师 REGISTERED POWER ENGINEER 注册安全工程师 REGISTERED SAFETY ENGINEER 注册环境影响评价工程师 REGISTERED ENVIRONMENTAL IMPACT ASSESSMENT ENGINEER 注册城乡规划师 REGISTERED URBAN AND RURAL PLANNING ENGINEER 注册测绘师 REGISTERED SURVEYING ENGINEER 注册土地估价师 REGISTERED LAND APPRAISER 注册资产评估师 REGISTERED ASSET APPRAISER 注册税务师 REGISTERED TAX APPRAISER 注册造价工程师 REGISTERED COST ENGINEER 注册监理工程师 REGISTERED SUPERVISOR 注册咨询工程师 REGISTERED CONSULTING ENGINEER 注册安全评价师 REGISTERED SAFETY EVALUATOR 注册环境影响评价工程师 REGISTERED ENVIRONMENTAL IMPACT ASSESSMENT ENGINEER 注册城乡规划师 REGISTERED URBAN AND RURAL PLANNING ENGINEER 注册测绘师 REGISTERED SURVEYING ENGINEER 注册土地估价师 REGISTERED LAND APPRAISER 注册资产评估师 REGISTERED ASSET APPRAISER 注册税务师 REGISTERED TAX APPRAISER 注册造价工程师 REGISTERED COST ENGINEER 注册监理工程师 REGISTERED SUPERVISOR 注册咨询工程师 REGISTERED CONSULTING ENGINEER 注册安全评价师 REGISTERED SAFETY EVALUATOR			
图名 DRAWING TITLE			
工程编号 PROJECT NO.			
图例 LEGEND			
图号 DRAWING NO.			
日期 DATE			

专业	姓名	日期	专业	姓名	日期
建筑			暖通		
结构			电气		
给排水					



顶面布置图

建筑设计单位 ARCHITECTURE DESIGN UNIT		合作设计 CO-OPERATED UNIT		本图纸中所有标注尺寸均为准，尺寸不得随意。	
注册执业章 REGISTERED SEAL		日期 DATE		版本 VERSION	
项目负责人 PROJECT DIRECTOR		日期 DATE		版本 VERSION	
专业负责人 DISCIPLINE RESPONSIBLE		日期 DATE		版本 VERSION	
审核 CHECKED BY		日期 DATE		版本 VERSION	
设计 DESIGNED BY		日期 DATE		版本 VERSION	
项目名称 PROJECT NAME		日期 DATE		版本 VERSION	
图名 DRAWING TITLE		日期 DATE		版本 VERSION	
图别 DRAWING TYPE		日期 DATE		版本 VERSION	
图号 DRAWING NO.		日期 DATE		版本 VERSION	
日期 DATE		日期 DATE		版本 VERSION	


专业	姓名	日期	专业	姓名	日期
建筑			暖通		
结构			电气		
给排水					



灯具尺寸图

建筑设计单位 ARCHITECTURE DESIGN UNIT		合作设计 CO-OPERATION FIRM		本图纸中所有标注尺寸均为准，尺寸不得随意更改。	
注册执业资格 REGISTERED QUALIFICATION		日期 DATE		版本 VERSION	
项目负责人 PROJECT DIRECTOR		日期 DATE		版本 VERSION	
专业负责人 SPECIALIST IN CHARGE		日期 DATE		版本 VERSION	
审核 CHECK		日期 DATE		版本 VERSION	
设计 DESIGN		日期 DATE		版本 VERSION	
项目名称 PROJECT NAME		日期 DATE		版本 VERSION	
图名 DRAWING TITLE		日期 DATE		版本 VERSION	
图号 DRAWING NO.		日期 DATE		版本 VERSION	
图别 DRAWING TYPE		日期 DATE		版本 VERSION	
日期 DATE		日期 DATE		版本 VERSION	


专业	姓名	日期	专业	姓名	日期
建筑			暖通		
结构			电气		
给排水					

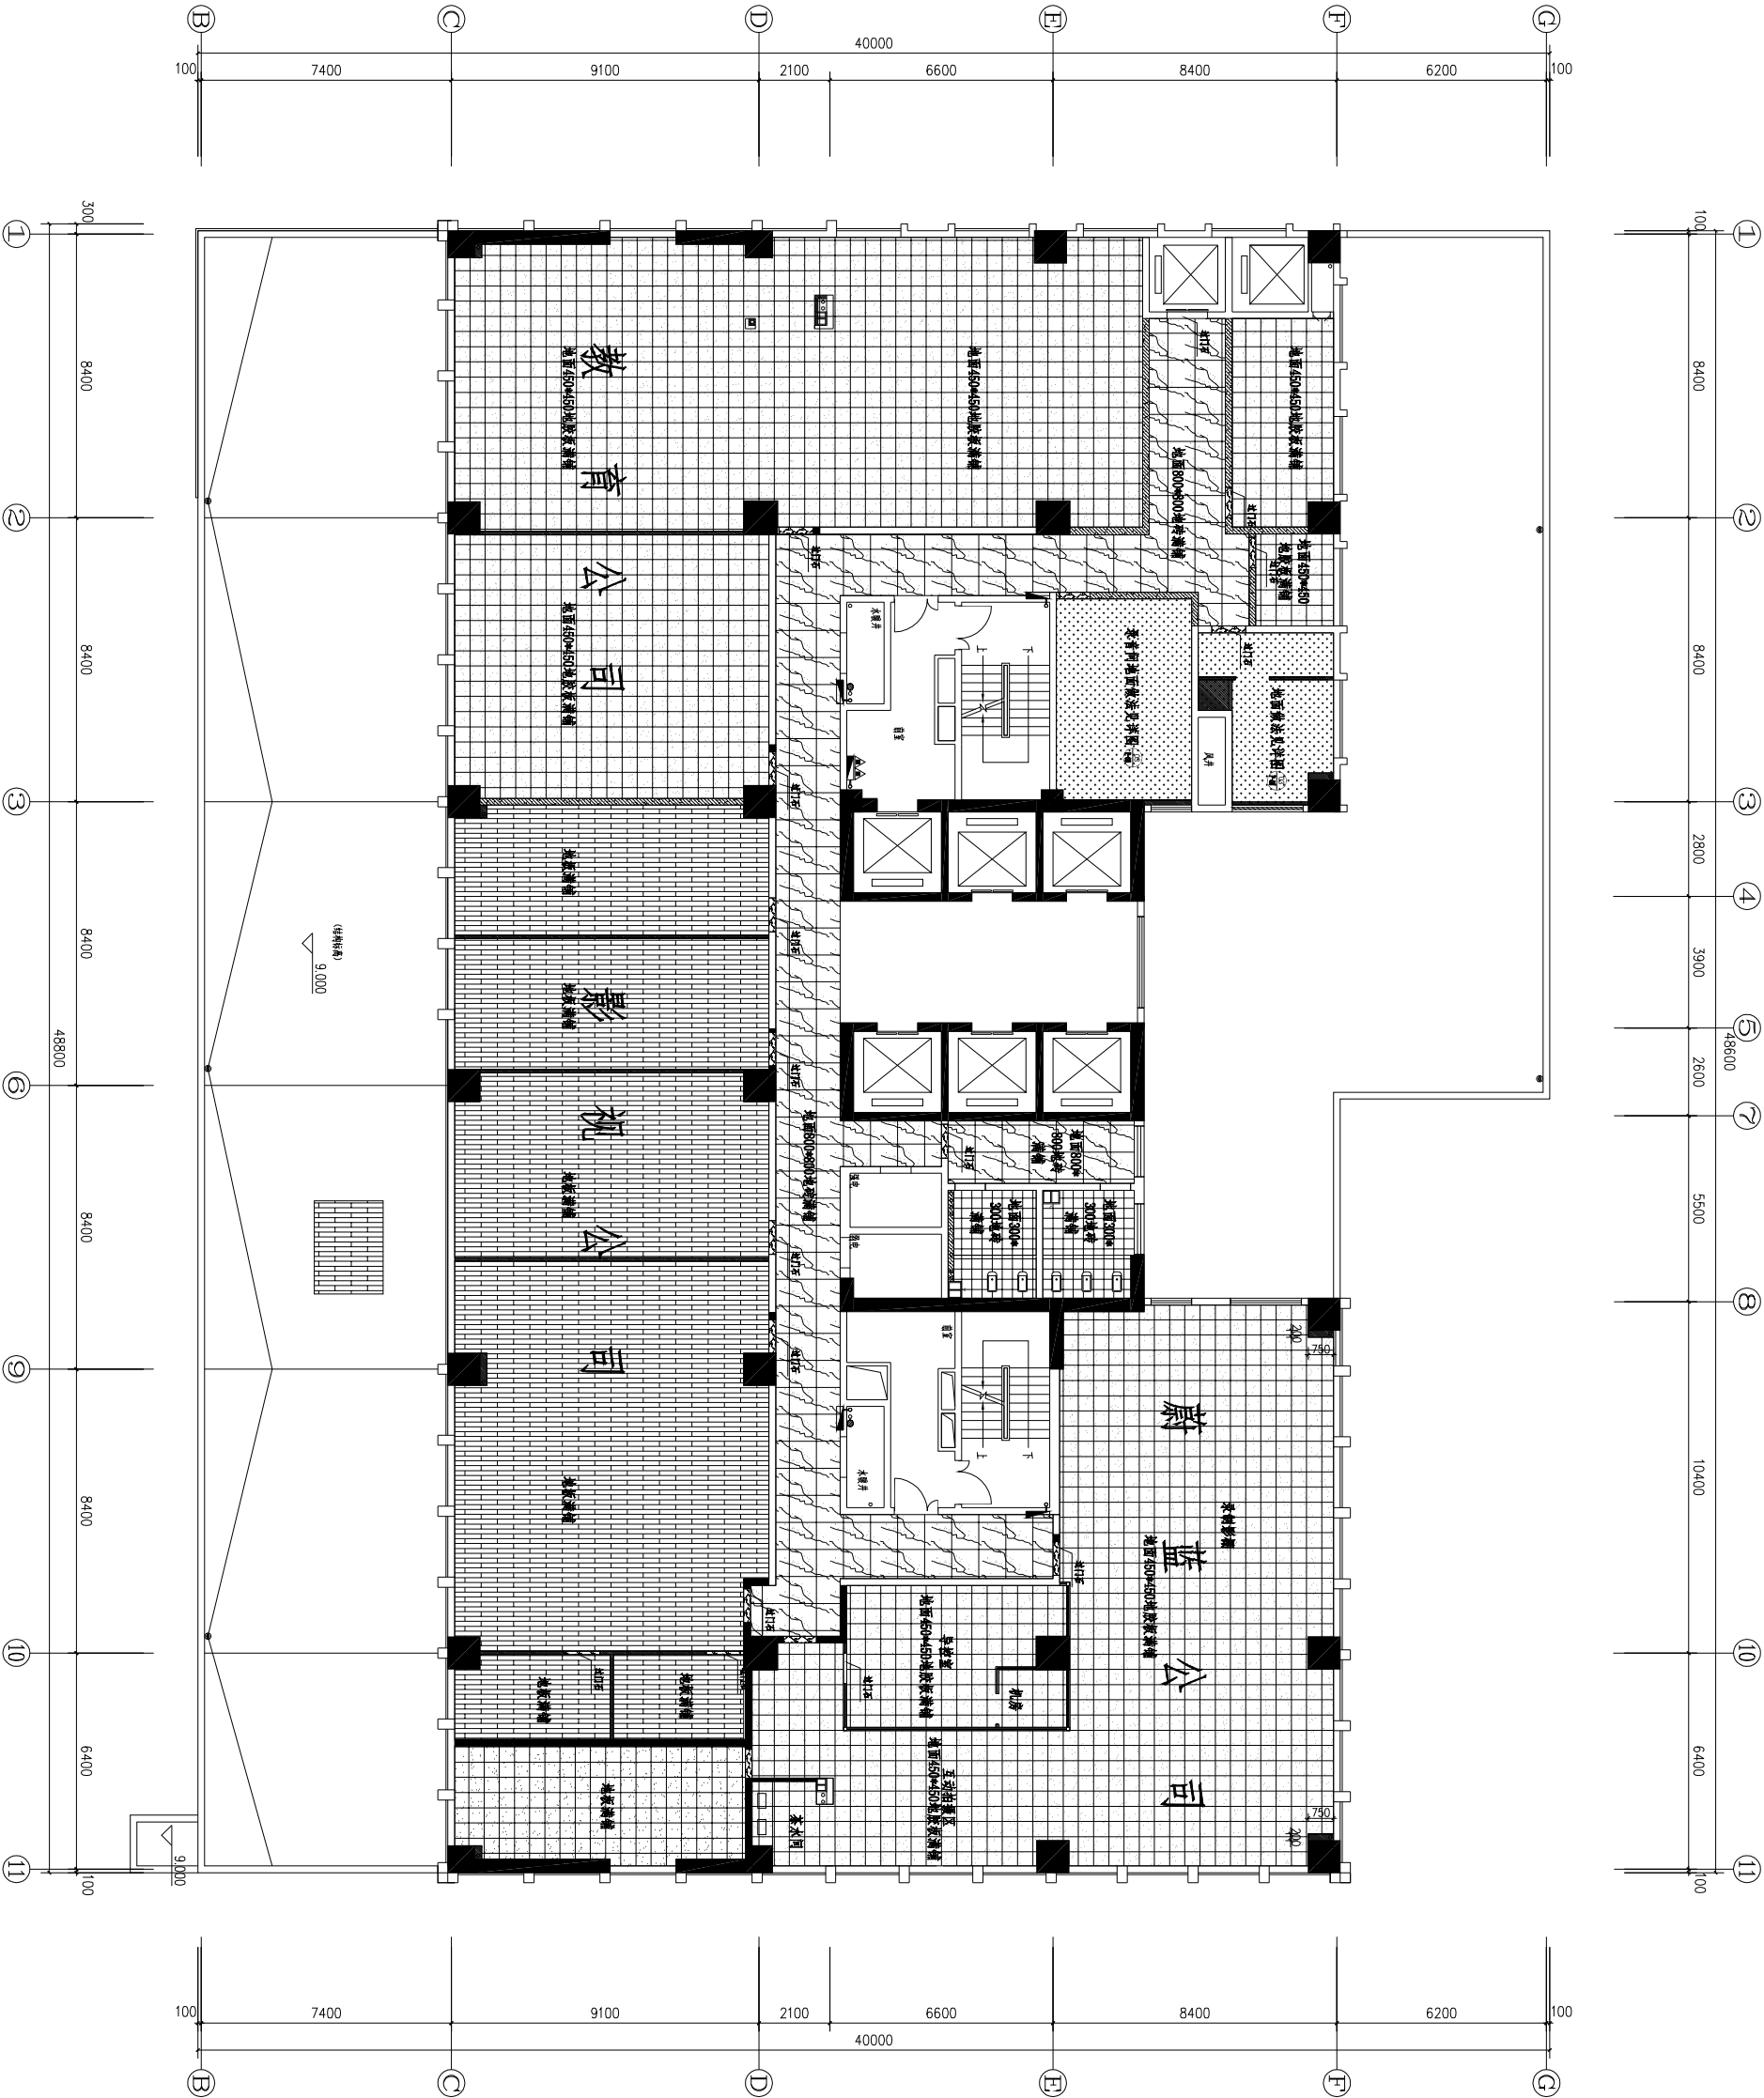

地面铺装图

建筑设计单位 ARCHITECTURE DESIGN UNIT			
合作设计 CO-OPERATION FIRM			
本图纸中以标注尺寸为准，尺寸不得测量。			
日期 版本 日期 版本 日期 版本 日期 版本			
注册执业章 REGISTERED SEAL			
项目定章 PROJECT NAME			
图名 DRAWING TITLE			
工程编号 PROJECT NO.			
图别 STATUS			
图号 DRAWING NO.			
日期 DATE			

专业	姓名	日期	专业	姓名	日期
建筑			暖通		
结构			电气		
给排水					

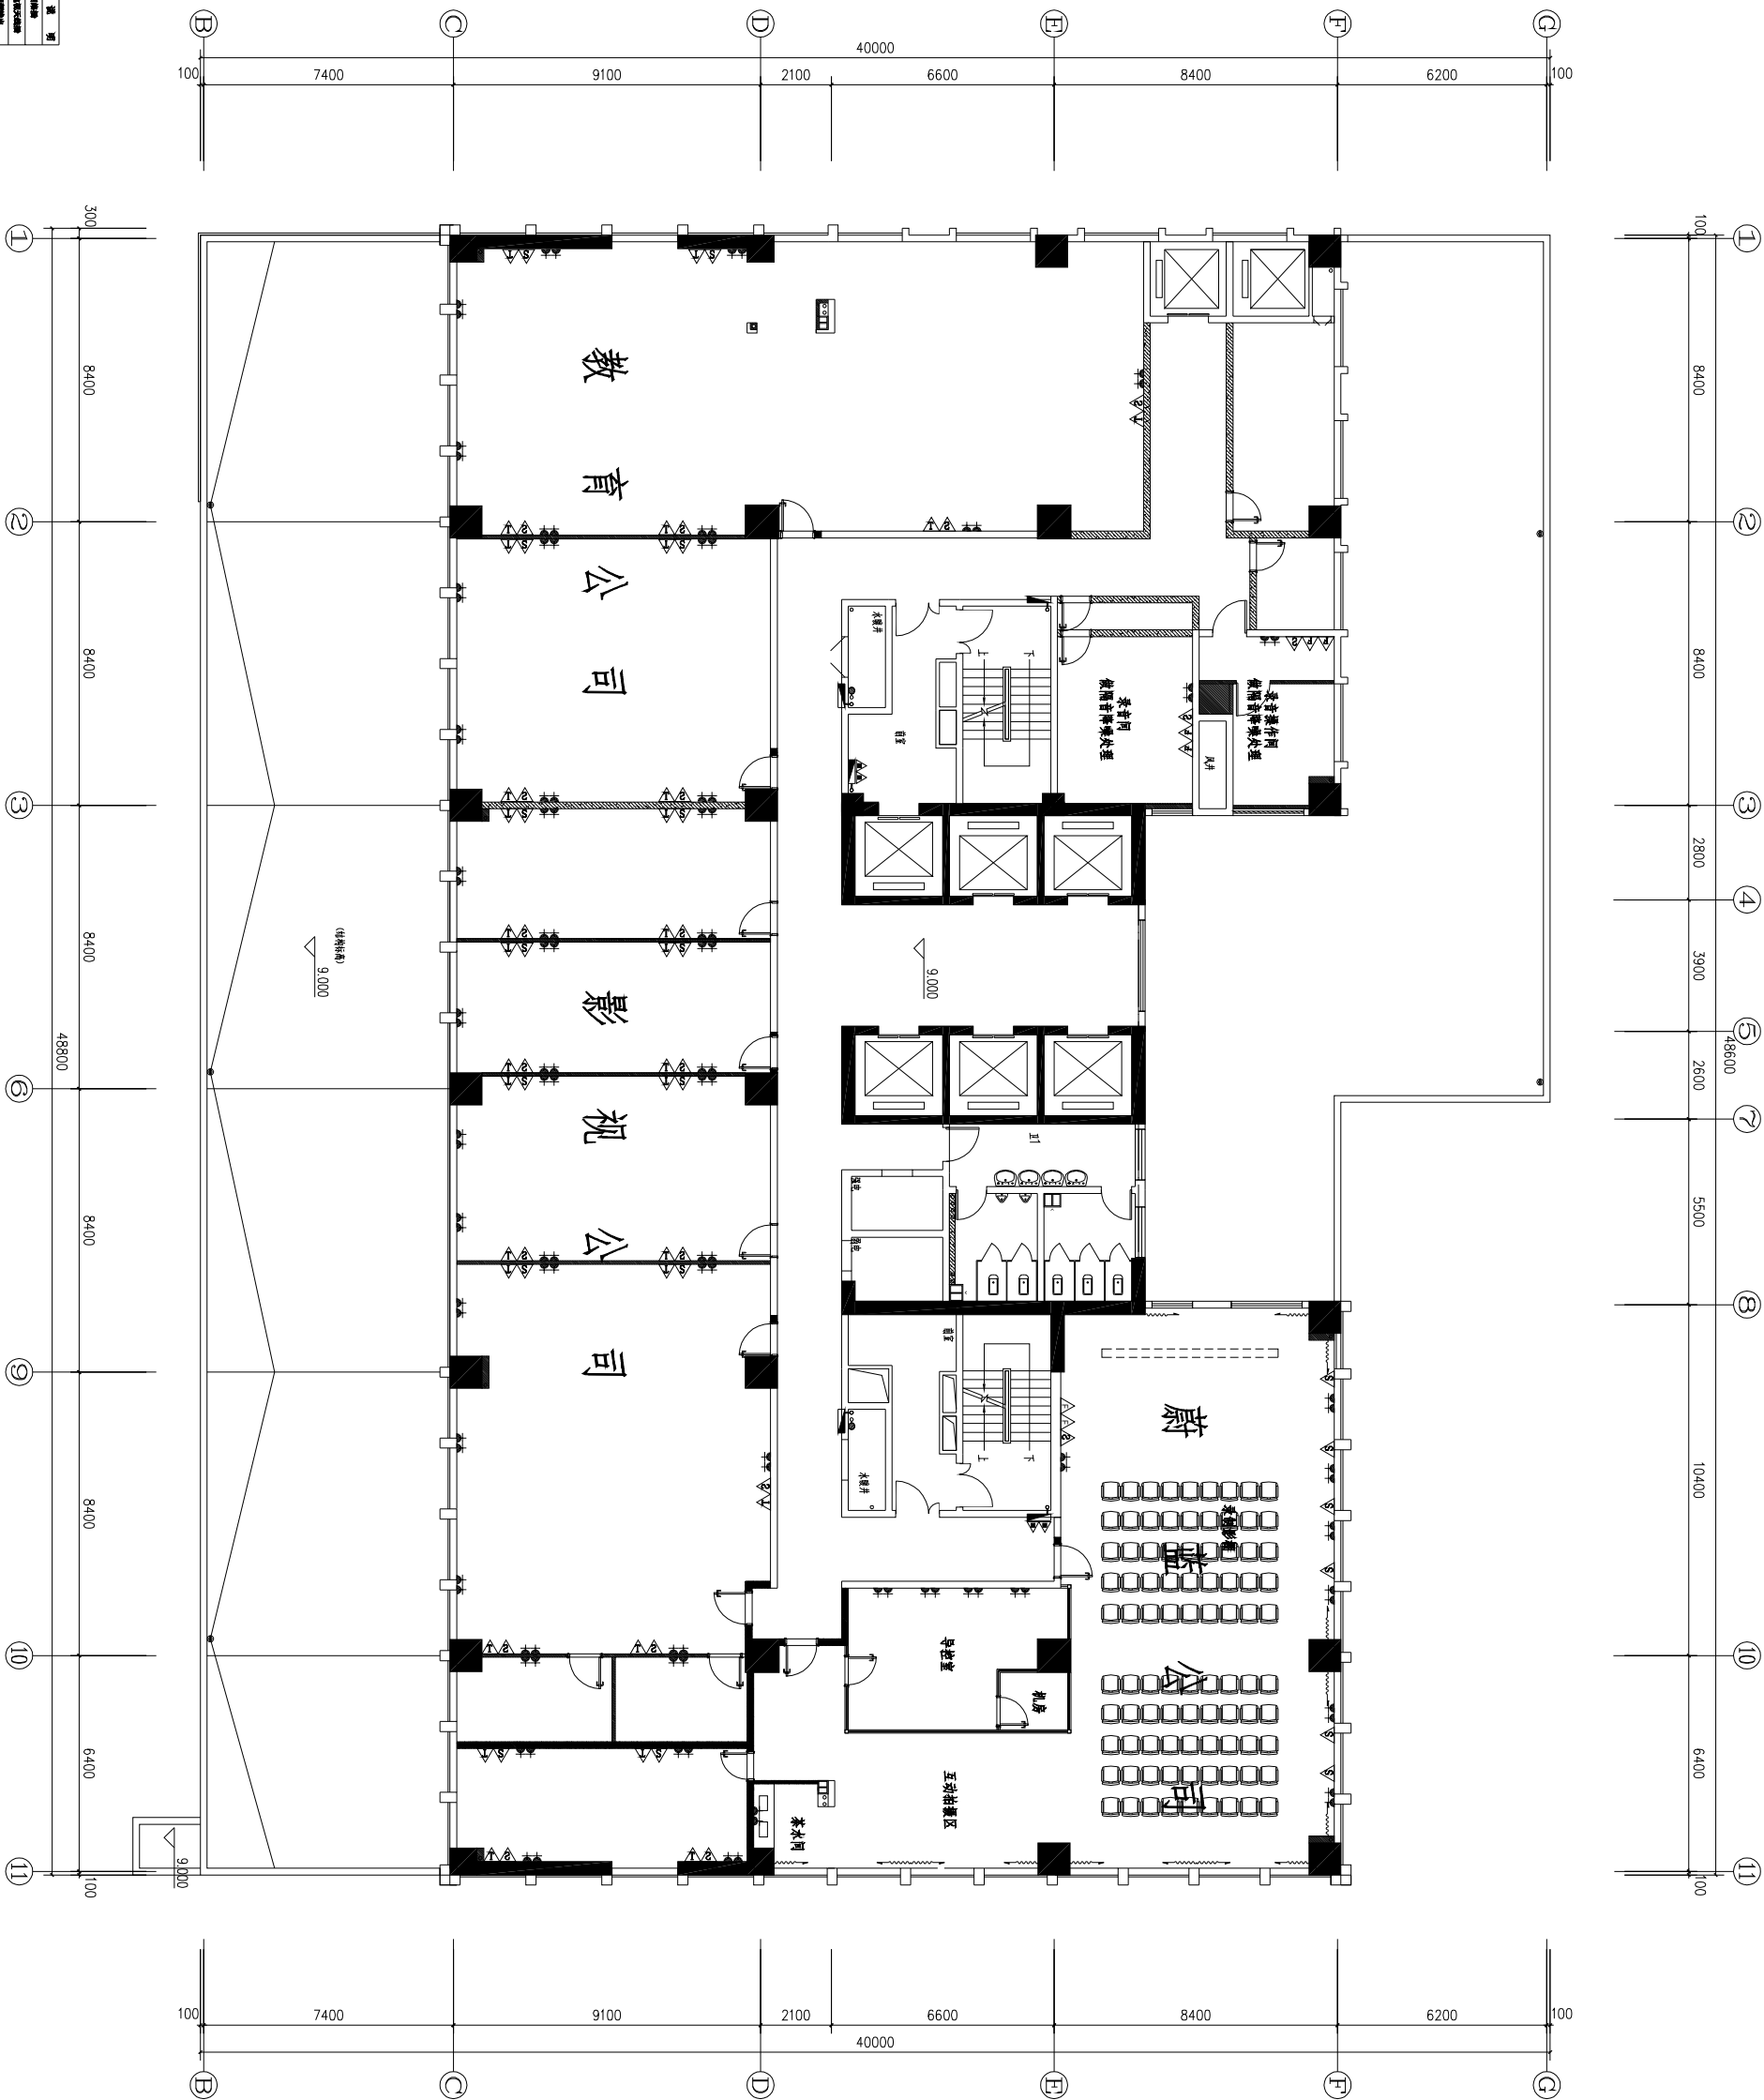


照制流明	照制说明
✓	脚踏开关
✓	双联单控开关
✓	三联单控开关
✓	调光开关
✓	双联双控开关
✓	三叉灯
✓	三路双控开关
✗	三路单控
✗	普通插座
△	电话插

插座布置图




建筑设计单位 ARCHITECTURAL DESIGN UNIT			
合作设计 CO-OPERATE FIRM			
本图纸中以所注尺寸为准，尺寸不得测量。			
注册执业章 REGISTERED SEAL			
审核章 CHECK PROJECT SEAL			
日期			
版本	原始版	修改1版	修改2版
审定 APPROVED BY 项目负责人 PROJECT MANAGER 专业负责人 SPECIALIST IN RESPONSIBLE BY 校对人 CHECKED BY 设计 DESIGNED BY			
工程名称 PROJECT NAME			
项目名称 ITEM NAME			
图名 DRAWING TITLE 标准布置图			
工程编号 PROJECT NO.	2019-10		
图例 DRAWING NO.			
图号 DRAWING NO.	P-07		
日期 DATE	2019/10/10		

专业	姓名	日期	专业	姓名	日期
建筑			暖通		
结构			电气		
给排水					

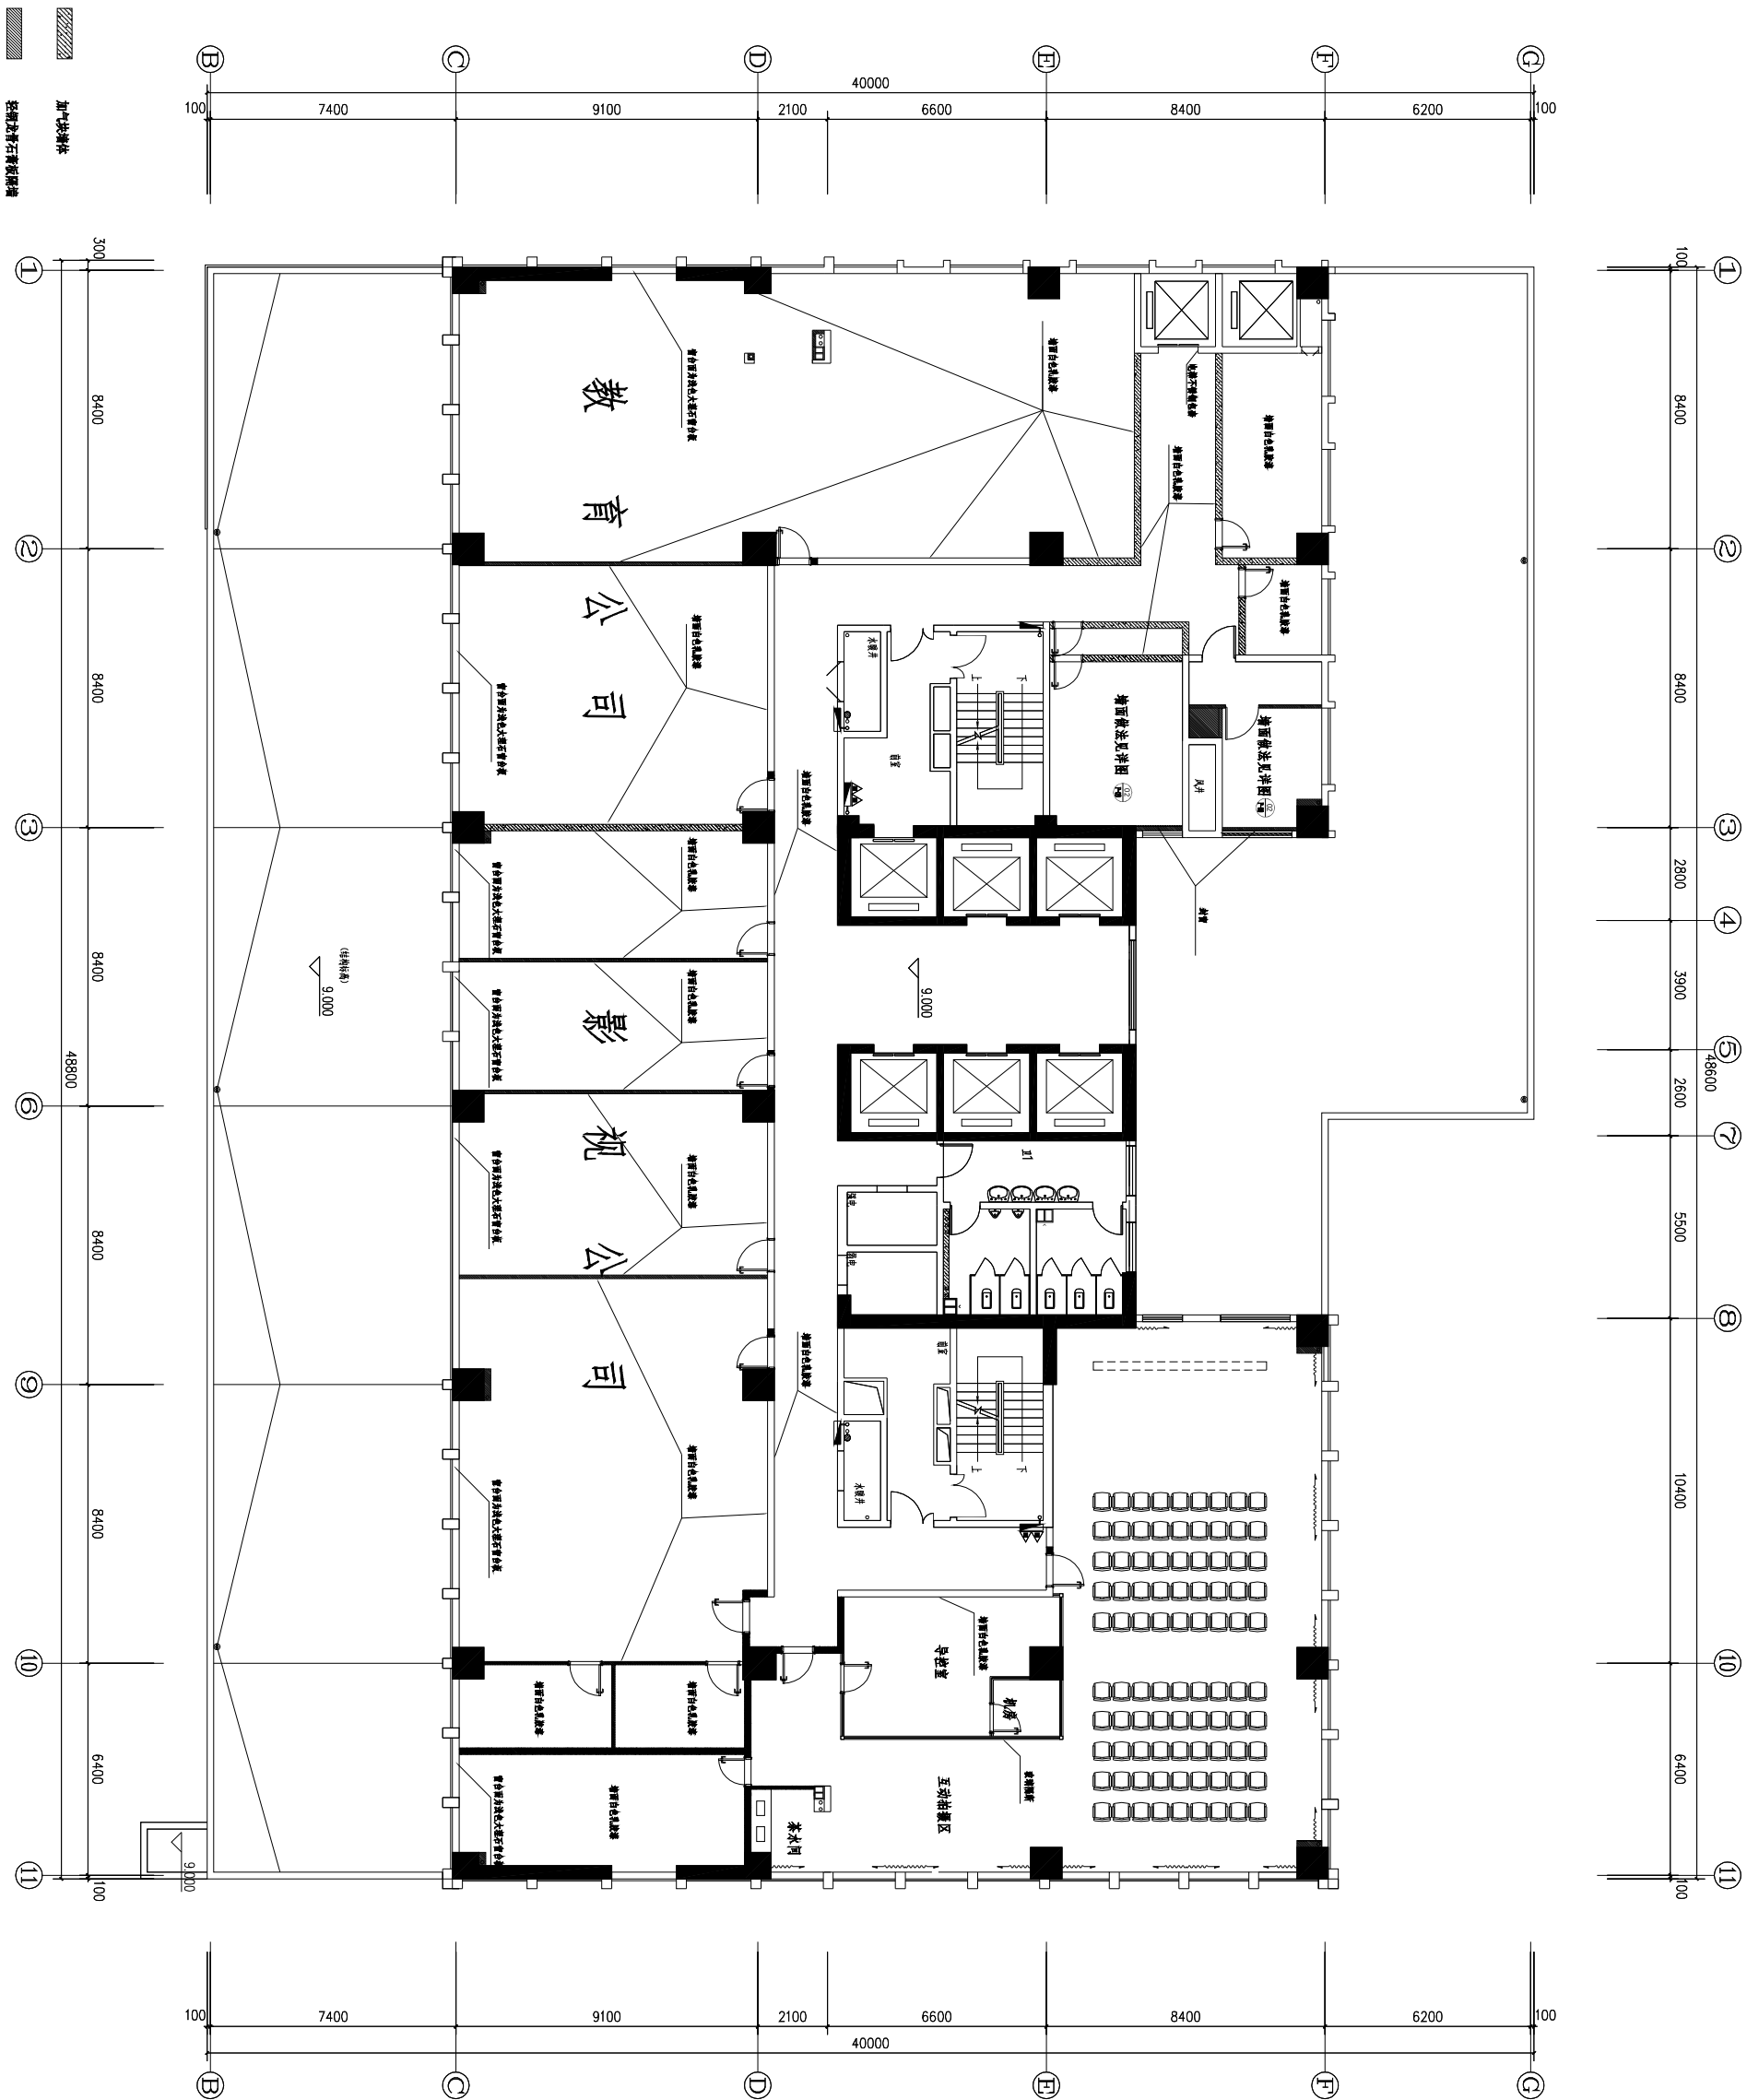

建筑设计单位 ARCHITECTURAL DESIGN UNIT			
合作设计 CO-DESIGN TITLE			
本图纸中以标注尺寸为准，尺寸不得随意。			
注册建筑师 REGISTERED ARCHITECT			
注册结构师 REGISTERED STRUCTURAL ENGINEER			
注册设备工程师 REGISTERED EQUIPMENT ENGINEER			
注册电气工程师 REGISTERED ELECTRICAL ENGINEER			
注册暖通工程师 REGISTERED HEATING ENGINEER			
注册给排水工程师 REGISTERED WATER SUPPLY ENGINEER			
注册岩土工程师 REGISTERED GEOTECHNICAL ENGINEER			
注册城乡规划师 REGISTERED URBAN PLANNING ENGINEER			
注册风景园林师 REGISTERED LANDSCAPE ARCHITECT			
注册造价工程师 REGISTERED COST ENGINEER			
注册监理工程师 REGISTERED SUPERVISOR			
注册安全工程师 REGISTERED SAFETY ENGINEER			
注册环境影响评价工程师 REGISTERED ENVIRONMENTAL IMPACT ASSESSMENT ENGINEER			
注册咨询工程师 REGISTERED CONSULTANT ENGINEER			
注册资产评估师 REGISTERED ASSET APPRAISER			
注册税务师 REGISTERED TAX AGENT			
注册会计 REGISTERED ACCOUNTANT			
注册审计师 REGISTERED AUDITOR			
注册资产评估师 REGISTERED ASSET APPRAISER			
注册税务师 REGISTERED TAX AGENT			
注册会计 REGISTERED ACCOUNTANT			
注册审计师 REGISTERED AUDITOR			
注册资产评估师 REGISTERED ASSET APPRAISER			
注册税务师 REGISTERED TAX AGENT			
注册会计 REGISTERED ACCOUNTANT			

专业	姓名	日期	专业	姓名	日期
建筑			暖通		
结构			电气		
给排水					

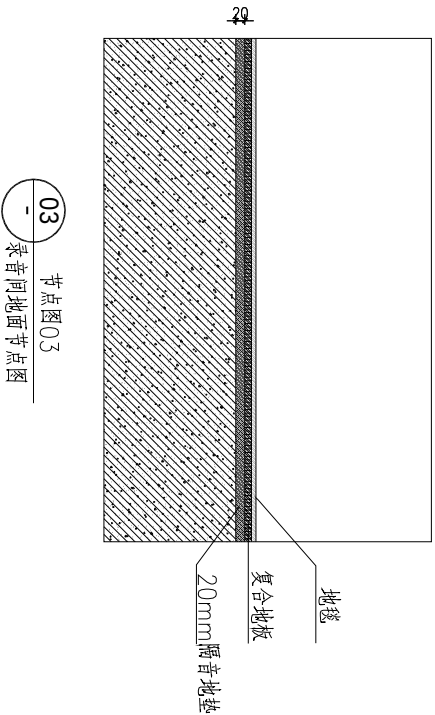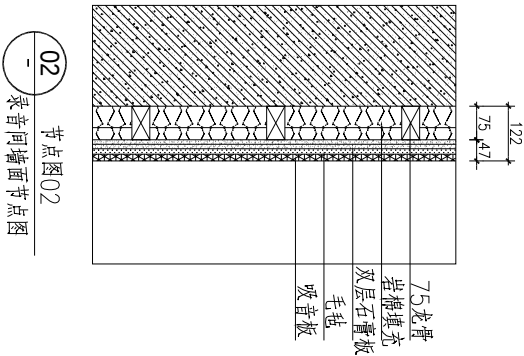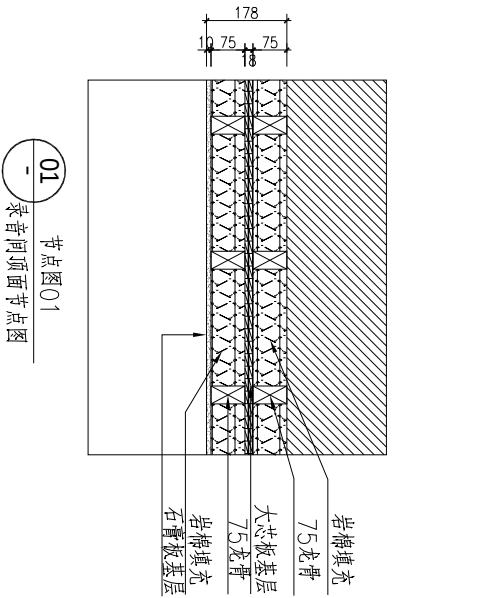

总设计师单位 ARCHITECTURE DESIGN UNIT		
合作设计 CO-DESIGNED BY		
本图纸中所有标注尺寸均为净尺寸，尺寸不得测量。		
注册执业章 REGISTERED SEAL		
设计章 DESIGN PROJECT SEAL		
日期	版本	修改记录
版本	• 原始版	• 修改1版
• 修改2版		
图名 DRAWING TITLE		
工程编号 PROJECT NO.		
图别 DRAWING TYPE		
图号 DRAWING NO.		
日期 DATE		